


not built.

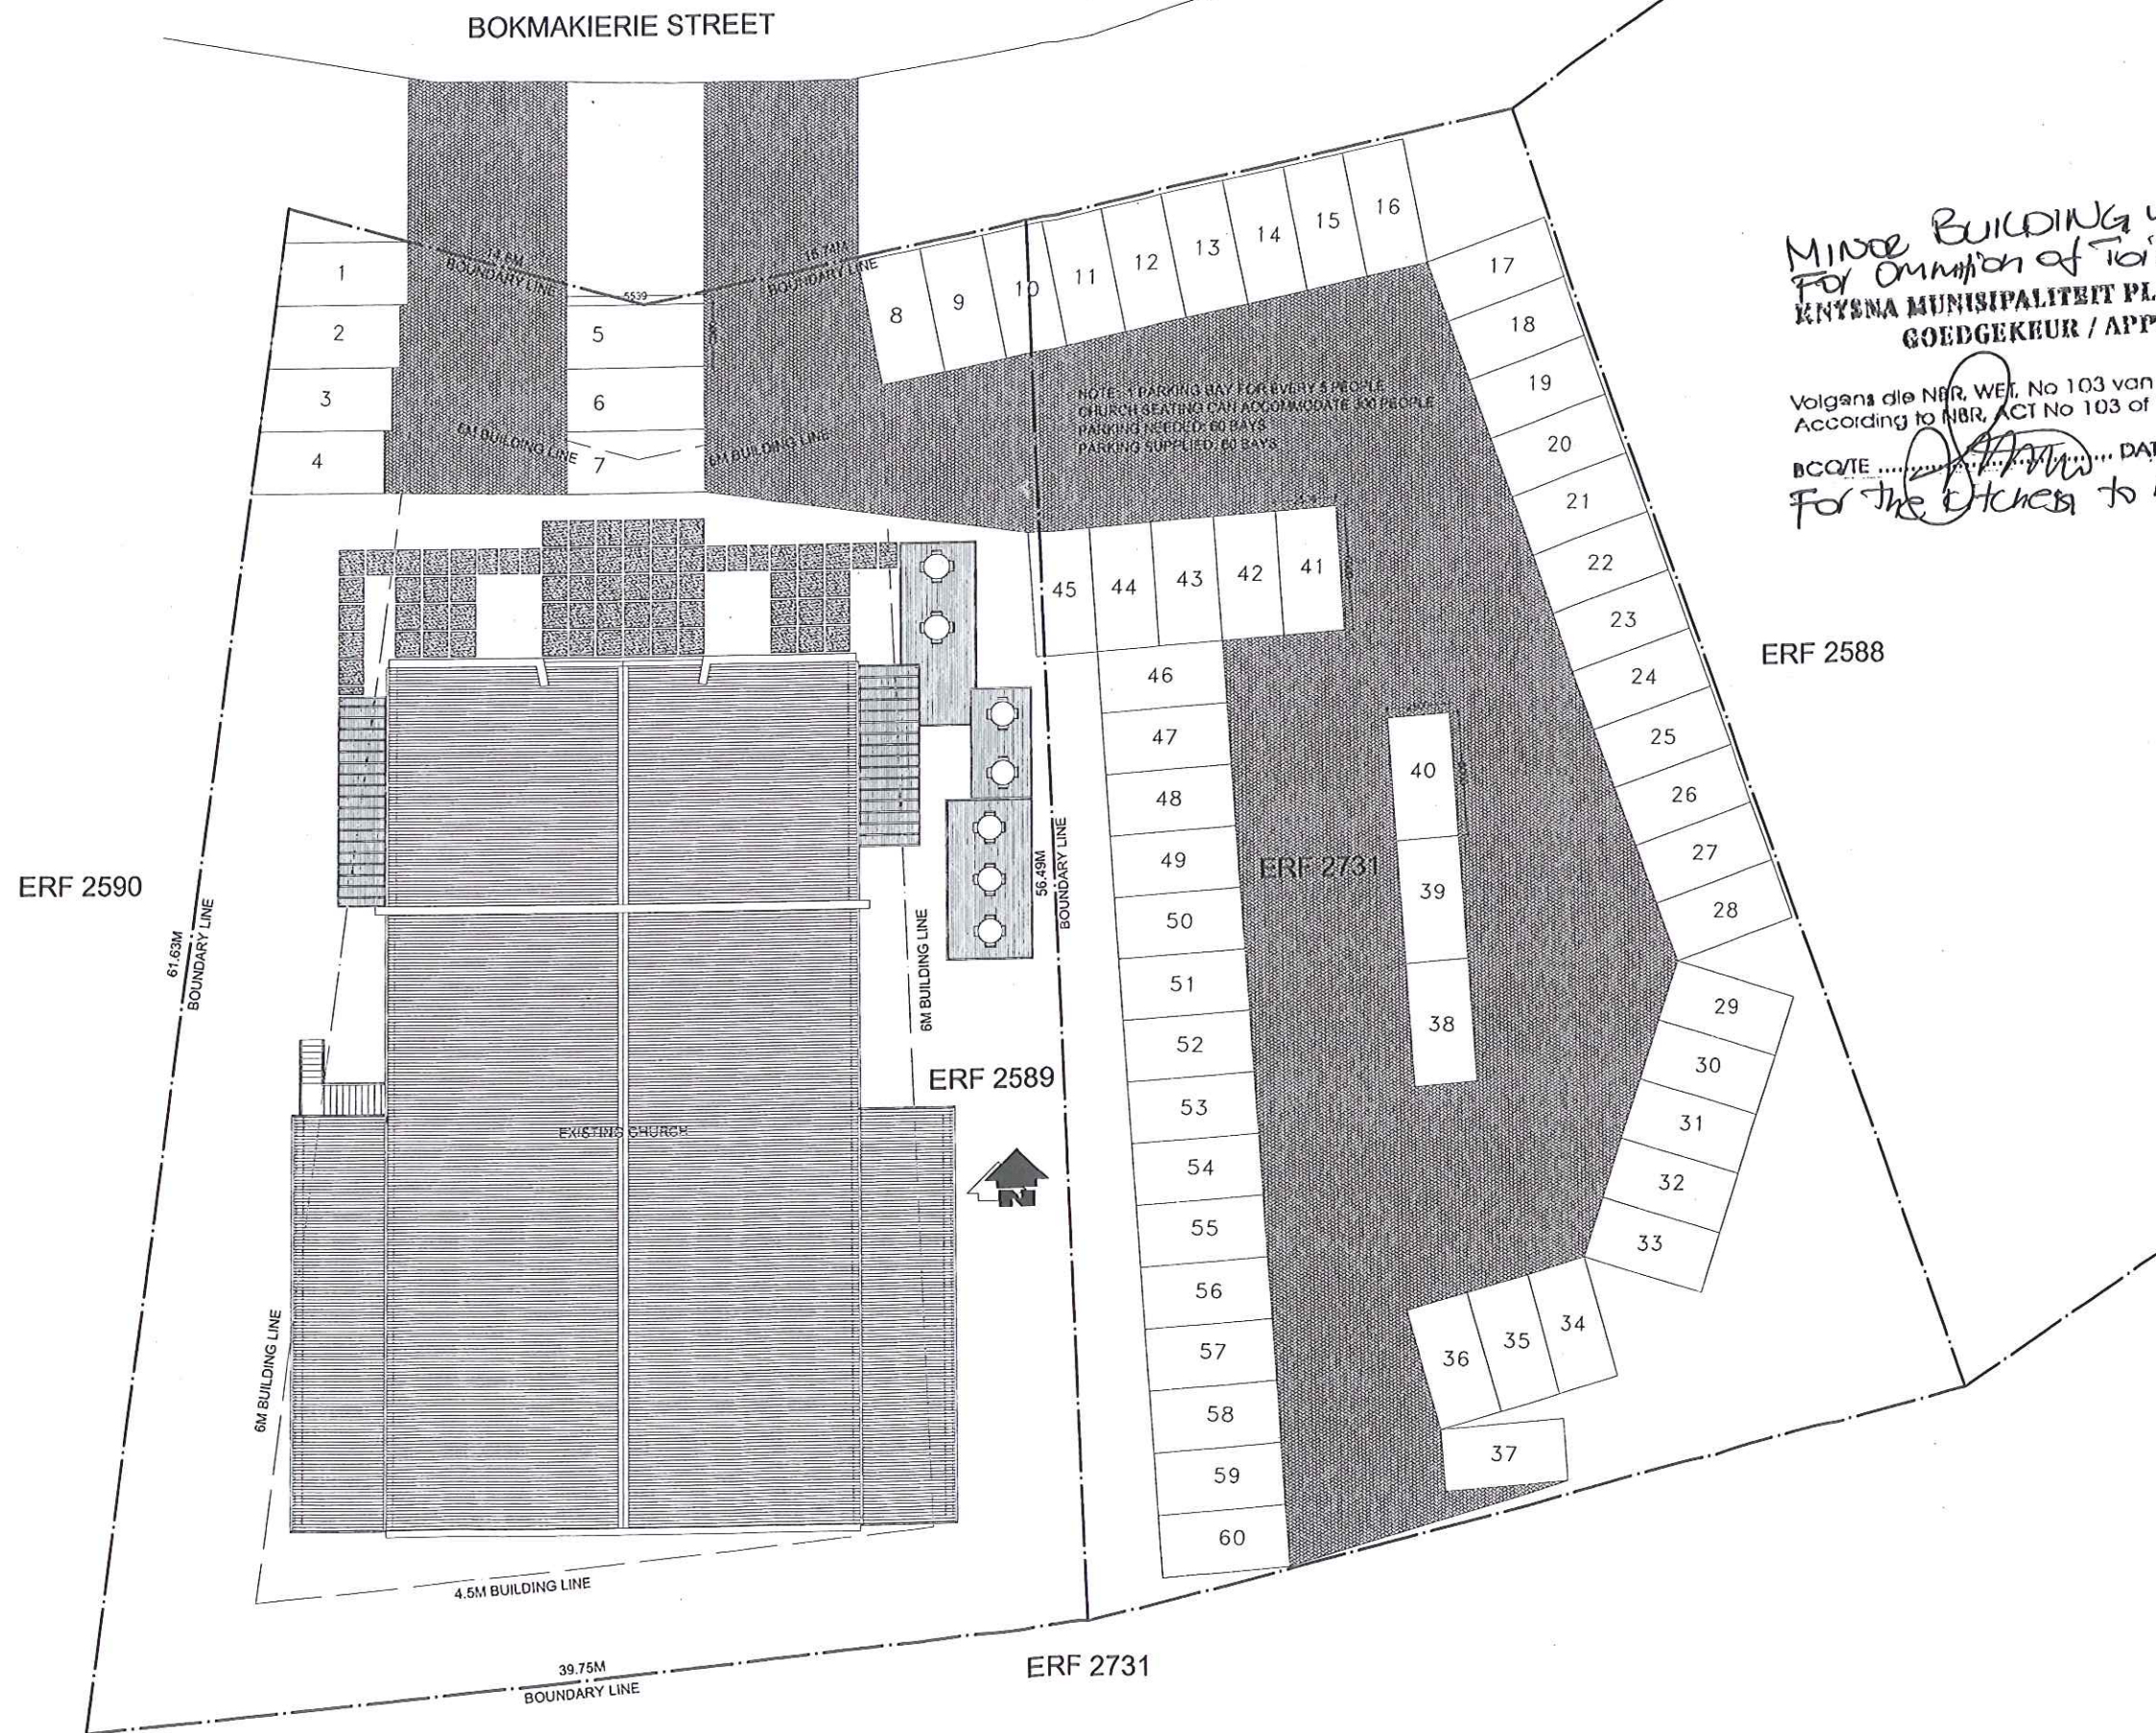

MINOR BUILDING WORKS APPROVAL
For Addition of Toilet Facilities & Screening
KNYSNA MUNICIPALITEIT PLAN No.....
GOEDGEKEUR / APPROVED
Volgens die NBR, WET, No 103 van 1977 soos gewysig
According to NBR, ACT No 103 of 1977 as amended
DATE: 23/03/17
For the church to be built

SITE PLAN (PARKING)-1:200

DRAWING:
SITE PLAN (PARKING)

PROPOSED ALTERATIONS
KNYSNA ERF 2589
FOR VINEYARD CHURCH

DWG NO:
1535-02-A2-07

SCALE:
1:200 @ A2

DATE:
25 JULY 2016


DRAWN:
MAM

STARKEY|OLIVIER
ARCHITECTS.

KNYSNA: +27 (0) 21 44 582 4128
CAPE TOWN: +27 (0) 21 44 582 4129
EMAIL: info@starkeyolivier.co.za
WEB: www.starkeyolivier.co.za

NOTE: DRAWING REMAINS THE PROPERTY OF THE ARCHITECT
DRAWING NOT TO BE SCALED
ALL WORK TO BE DONE TO NATIONAL BUILDING REGULATIONS
AND LOCAL BY-LAWS
ALL DIMENSIONS TO BE CHECKED ON SITE

not built.

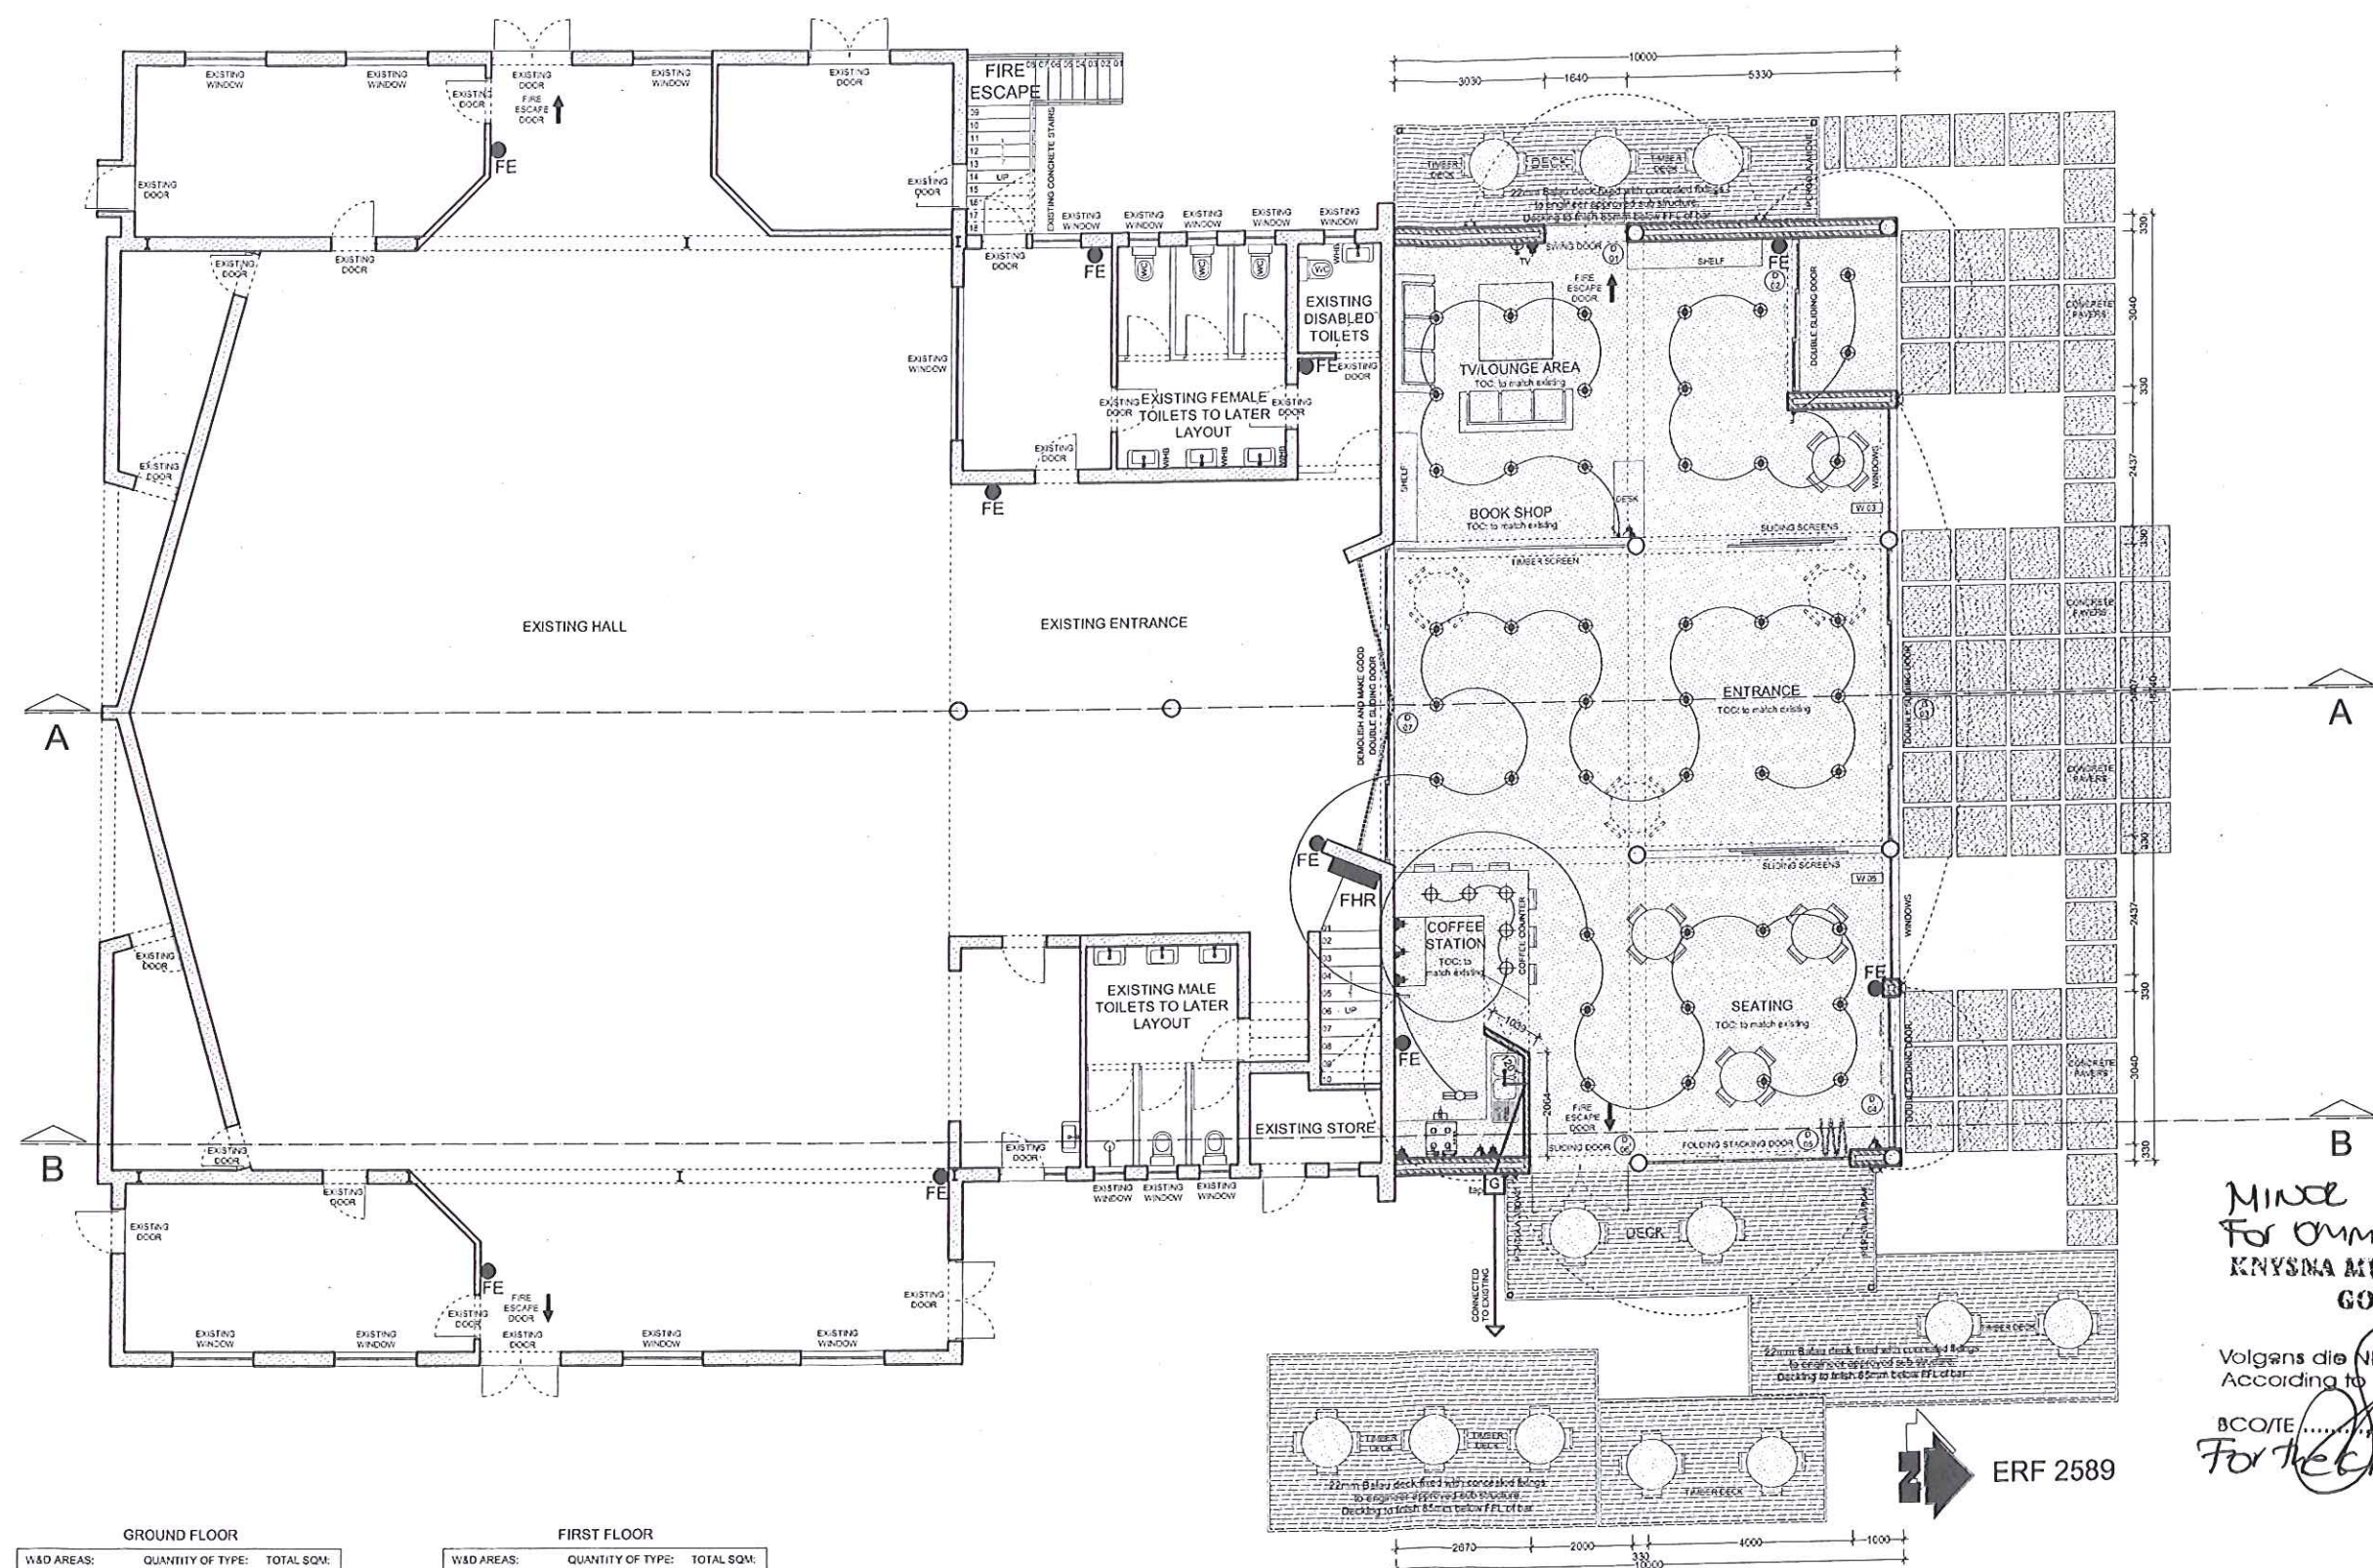

GROUND FLOOR

W&D AREAS:	QUANTITY OF TYPE:	TOTAL SQM:
1. 29m²	01	29m²
2. 12.2m²	02	24.4m²
3. 7.6m²	01	7.6m²
4. 0.5m²	01	0.5m²
5. 0.8m²	01	0.8m²
6. 0.5m²	01	0.5m²
7. 5m²	01	5m²
8. 10m²	01	10m²
9. 0.3m²	10	3m²
10. 4m²	01	4m²
11. 1.5m²	03	4.5m²
TOTAL:		105.6m²
INTERNAL FLOOR AREA:		770m²
% FLAT WINDOW TO TOTAL FLOOR AREA:		13.7%

FIRST FLOOR

W&D AREAS:	QUANTITY OF TYPE:	TOTAL SQM:
1. 6m²	01	6m²
2. 0.6m²	03	1.8m²
3. 1.5m²	02	3m²
4. 1.2m²	11	13.2m²
TOTAL:		24m²
INTERNAL FLOOR AREA:		325m²
% FLAT WINDOW TO TOTAL FLOOR AREA:		7.38%

WINDOWS ARE LESS THEN 15% OF THE TOTAL INTERNAL FLOOR AREA SO FENESTRATION CALCULATIONS ARE DEEMED TO SATISFY

GROUND STOREY PLAN-1:100

ELECTRICAL LEGEND

[Symbol]	DISTRIBUTION BOARD 1500mm ABOVE FLOOR LEVEL
[Symbol]	DOUBLE TUBE FLUORESCENT LIGHT FITTING
[Symbol]	CEILING MOUNTED LIGHT FITTING
[Symbol]	50 WATT LOW VOLTAGE CEILING MOUNTED DOWNLIGHTER
[Symbol]	WALL SURFACE MOUNTED LIGHT FITTING 1800mm ABOVE FLOOR LEVEL (UNLESS SHOWN OTHERWISE ON PLAN)
[Symbol]	WALL MOUNTED WATERPROOF LIGHT FITTING 1800mm ABOVE FLOOR LEVEL (UNLESS SHOWN OTHERWISE ON PLAN)
[Symbol]	LIGHT SWITCH 1050mm ABOVE FLOOR LEVEL
[Symbol]	SATELLITE DISH POSITION
[Symbol]	TV AERIAL CONNECTION 4M BOX
[Symbol]	CONTROL 4 DIMMER LIGHT SWITCH CIRCUIT
[Symbol]	SPEAKER BY SPECIALIST
[Symbol]	TOUCH PAD CONTROL POINT
[Symbol]	AMP POINT FOR INTEGRATED SOUND SYSTEM
[Symbol]	BACK TO ZERO END (UNLESS SHOWN OTHERWISE ON PLAN)
[Symbol]	DIMMERS
[Symbol]	TWO-WAY LIGHT SWITCH 1050mm ABOVE FLOOR LEVEL
[Symbol]	CONNECTION TO STOVE WITH 15 AMP PLUG POINT ON WALL ABOVE (1800mm) FOR COOKER HOOD UNIT
[Symbol]	OVEN CONNECTION
[Symbol]	ISOLATOR SWITCH FOR OVEN
[Symbol]	TELEPHONE CONNECTION 340mm ABOVE FLOOR LEVEL
[Symbol]	WALL MOUNTED SECURITY LIGHT
[Symbol]	DOUBLE 15 AMP PLUGPOINT 340mm ABOVE FLOOR LEVEL
[Symbol]	DOUBLE 15 AMP PLUGPOINT 1050mm ABOVE FFL
[Symbol]	FOOT LIGHT 340mm ABOVE FLOOR LEVEL
[Symbol]	EXTRACTOR FAN WITH OUTLET TO EXTERIOR/ROOF VOID
[Symbol]	COUNTER STRAIGHT POINT
[Symbol]	BASE MOUNT GARDEN PATH LIGHT
[Symbol]	MUNICIPAL METRE
[Symbol]	HOT WATER CYLINDER POINT
[Symbol]	L.E.D. STARLIGHT (DOWNLIGHT)
[Symbol]	L.E.D. STARLIGHT (UPLIGHT)
[Symbol]	8-PIN STARLIGHT
[Symbol]	FLUSH MOUNT WATERPROOF BOX FOR GARDEN LIGHTING

STORM-WATER KEY

[Symbol]	FB Fullsize RC and outlet with domed cover
[Symbol]	Direction of water flow on roofs & gutters
[Symbol]	DP Downpipe with in structure
[Symbol]	DP Downpipe from gutter

DRAINAGE KEY

[Symbol]	Stormwater drain (100mm)
[Symbol]	Stormwater drain (150mm)
[Symbol]	Stormwater drain (200mm)

FIRE KEY

[Symbol]	FHR Fire Hose Reel 30m radius
[Symbol]	FE Fire Extinguisher 2kg & 2.5kg

MINOR BUILDING WORKS Approval
For omission of toilet facilities & screens
KNYSMA MUNICIPALITEIT PLAN No.
GOEDGEKEUR / APPROVED

Volgens die NBR, WET, No 103 van 1977 soos gewysig
According to NBR, ACT No 103 of 1977 as amended
BCO/TE DATE 23/07/17
For the return to be kept

STARKEY|OLIVIER ARCHITECTS

KNYSMA - 071 463 3542/25
CAPE TOWN - 021 531 4540/5
EMAIL: info@starkeyolivier.co.za
WEB: www.starkeyolivier.co.za